


MATERIAL KEYING LEGEND:

- NOTES:
- CONTRACTOR TO PROVIDE NEW THERMOSTATIC CONTROL VALVES FOR ALL EXISTING STEAM RADIATORS
 - FINAL THERMOSTAT AND DIFFUSER LOCATIONS TO BE COORDINATED WITH ARCHITECT.
 - CONTRACTOR TO PROVIDE 4" CONCRETE PADS FOR ALL FLOOR MOUNTED EQUIPMENT.
- BOILER ROOM NOTES:
- A. FURNISH AND INSTALL ONE NATURAL GAS SAFETY DETECTION SYSTEM IN THE BOILER ROOM.
- ONE COMBUSTIBLE GAS DETECTION HEAD AND ONE CARBON MONOXIDE HEAD SHALL BE INSTALLED IN THE BOILER ROOM AT THE FRONT OF THE BOILERS ABOVE THE BURNERS.
- WIRING BETWEEN THE CONTROLLER AND DETECTION HEADS SHALL BE #18 AWG LOW VOLTAGE SHIELDED.
- B. GAS DETECTION UNIT SHALL BE SCOTT-BACHMACH NO. 51-7499 DUAL CHANNEL UNIT COMPLETE WITH GAS DISPLAY, ALARM WITH SILENCE, FLASHER INDICATOR FOR LIE MONITORING AND WITH REMOVE EXPLOSION PROOF DETECTORS.

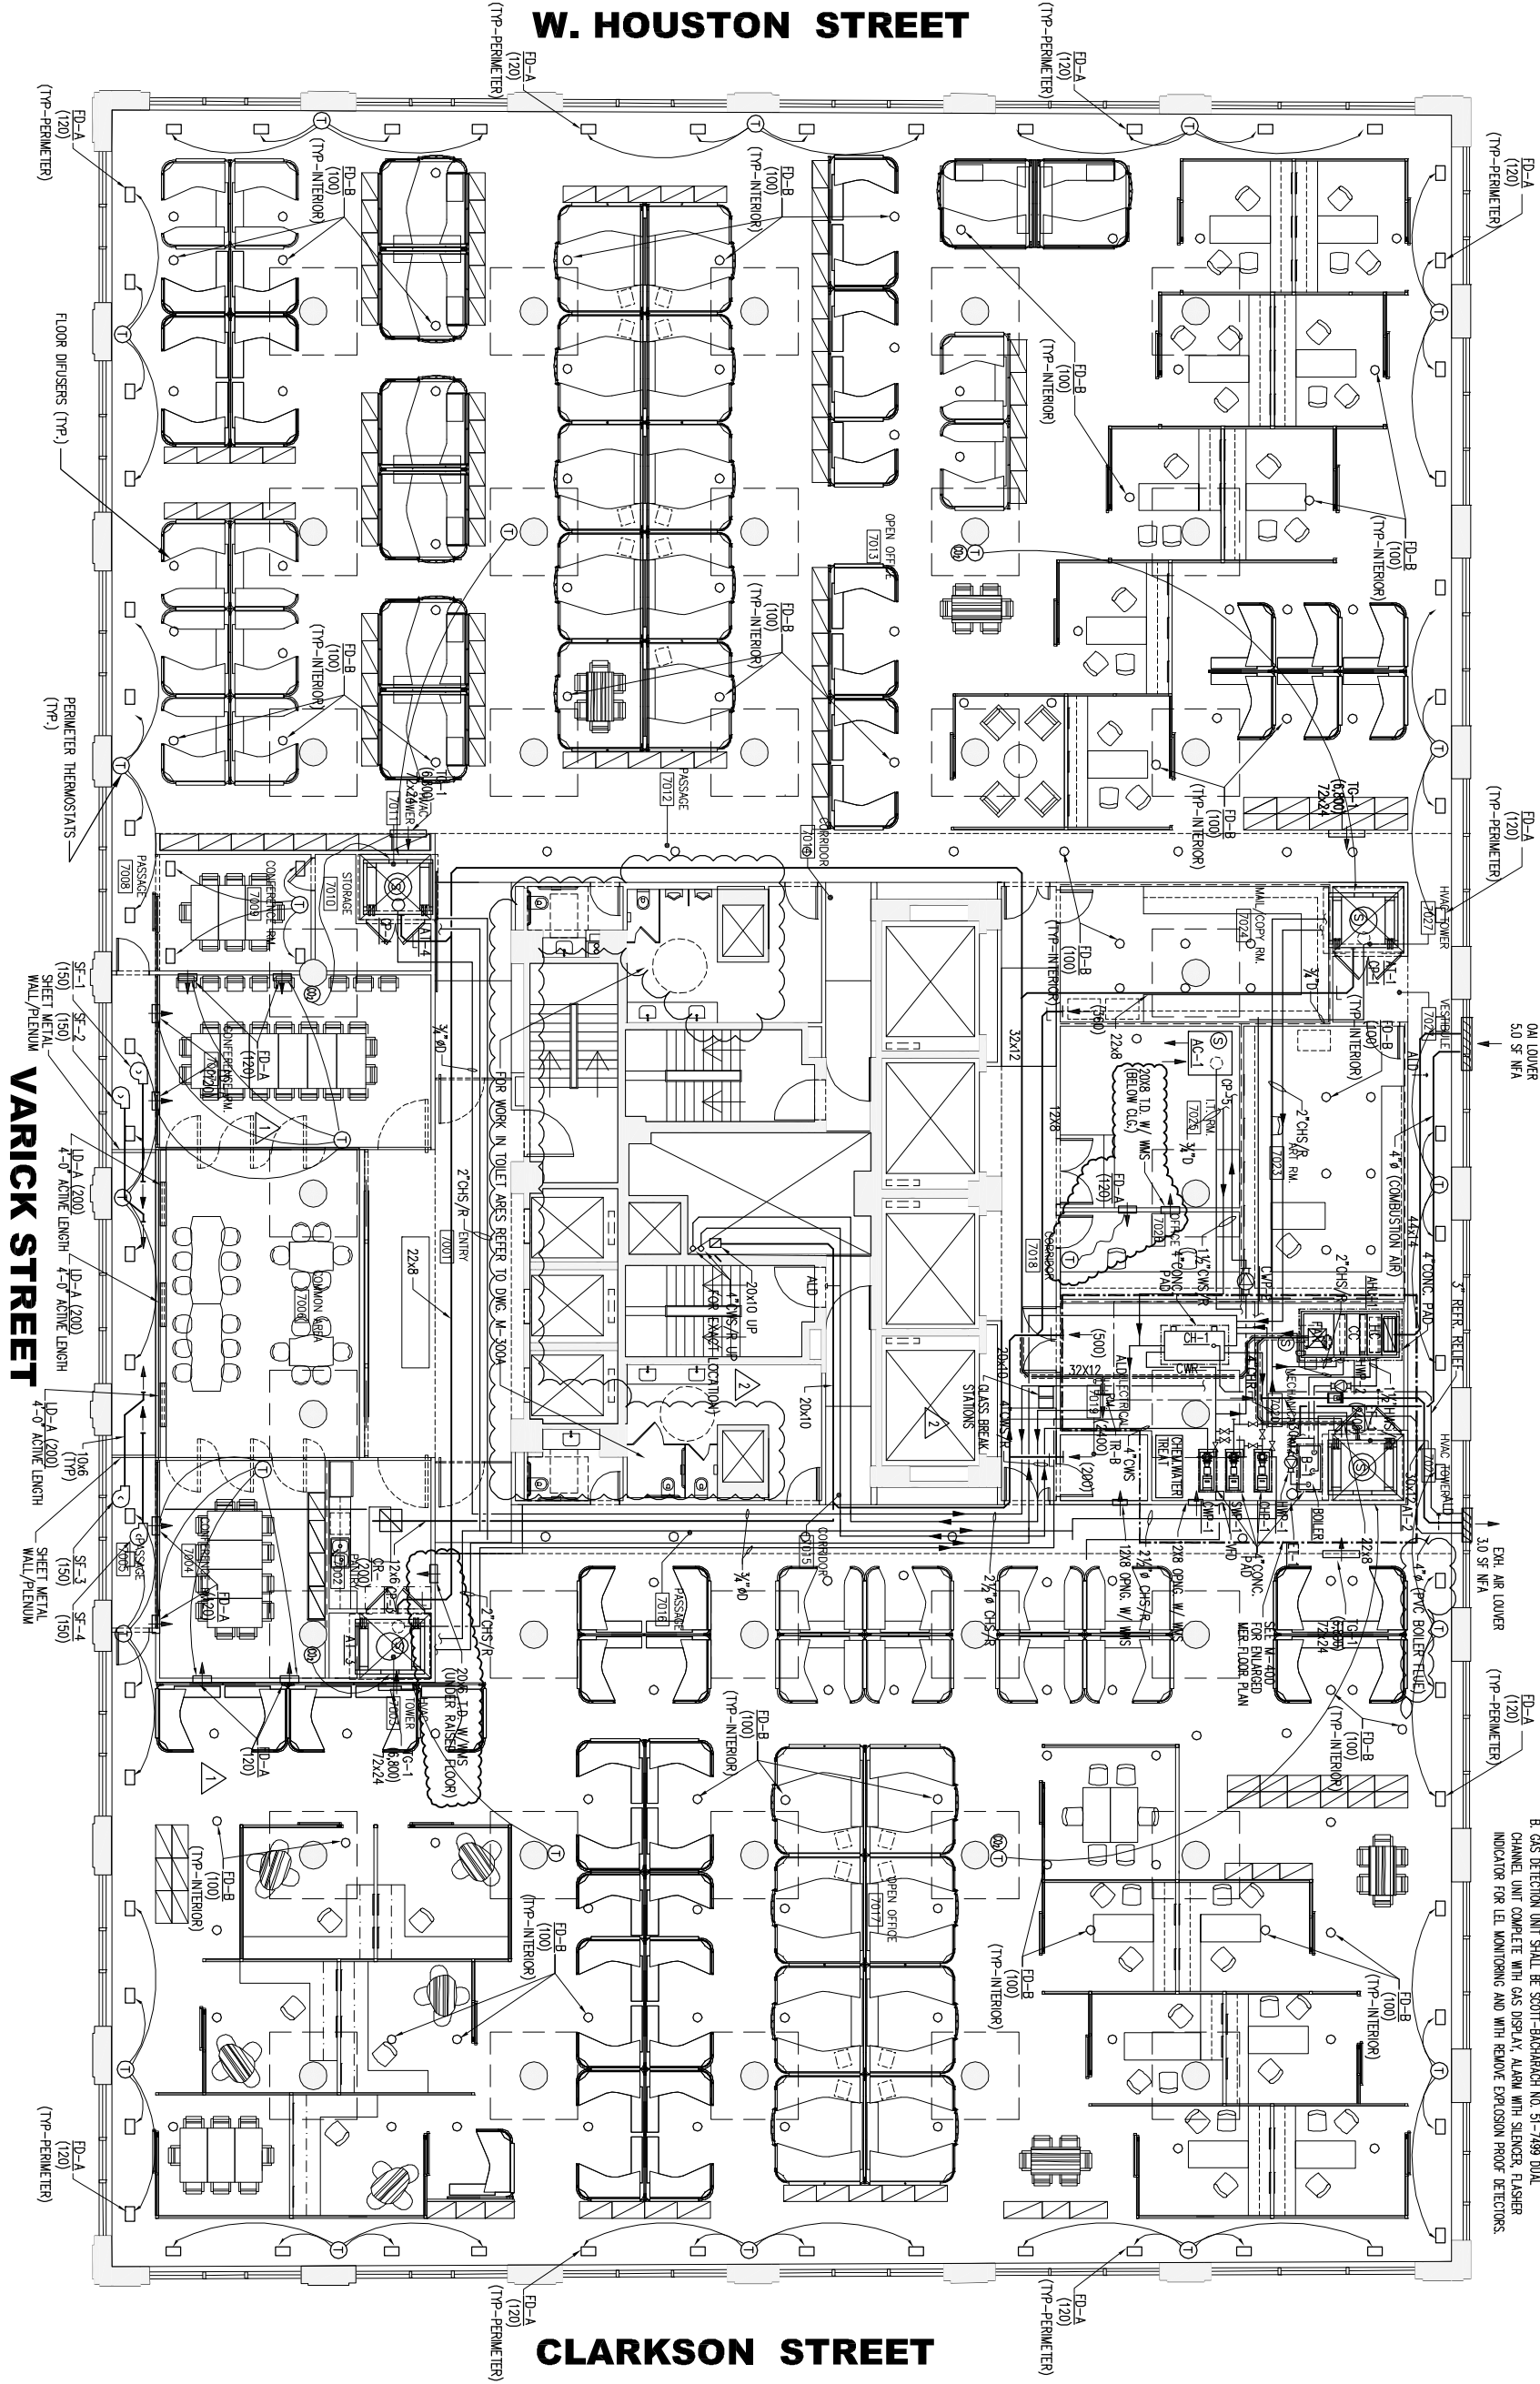

| | | |
|---|------------------------------|----------|
| 1 | ISSUE FOR CONSTRUCTION | 10.08.07 |
| 2 | ADDENDUM | 08.13.07 |
| 3 | ISSUE FOR BO | 08.00.07 |
| 4 | ISSUE FOR LANTCRO REVIEW | 07.20.07 |
| 5 | ISSUE FOR CONTRACT DOCUMENTS | 06.20.07 |
| 6 | 60% CD SUBMITTAL | 06.20.07 |
| 7 | REVISIONS / SUBMISSIONS | 06.20.07 |

PERVONE ARCHITECTS, P.C. 22 WEST 7TH STREET NEW YORK, NY 10011 | 212.627.1100 | 212.628.9791 | WWW.PERVONE.COM

FLACK + KURTZ
415 FIFTH AVENUE, NEW YORK, NY 10017 212.628.0830

ANASTOS ENGINEERING ASSOCIATES
240 WEST 58TH STREET NEW YORK, NY 10019 212.744.6833

ILLUMINATION ARTS, LLC LIGHTING CONSULTANTS
380 GREENWICH AVENUE, SUITE 207 BIRMINGHAM, AL 35203 878.717.5585

CERAMIC & ASSOCIATES, INC.
1501 BROADWAY, SUITE 1200 NEW YORK, NY 10036

YBC SUSTAINABILITY CONSULTANTS

THE NATIONAL AUDUBON SOCIETY
225 VARICK STREET, 7TH FLOOR | NEW YORK, NY 10014

DRAWING TITLE: **HVAC FLOOR PLAN**

Scale: 1/8" = 1'-0"

DATE: 06.08.07

DRAWING NO.: **M-300**

Drawn: TS Project No.: N06.30670.00

Checked: Calf PFK

Reviewed: Drawing No.: